



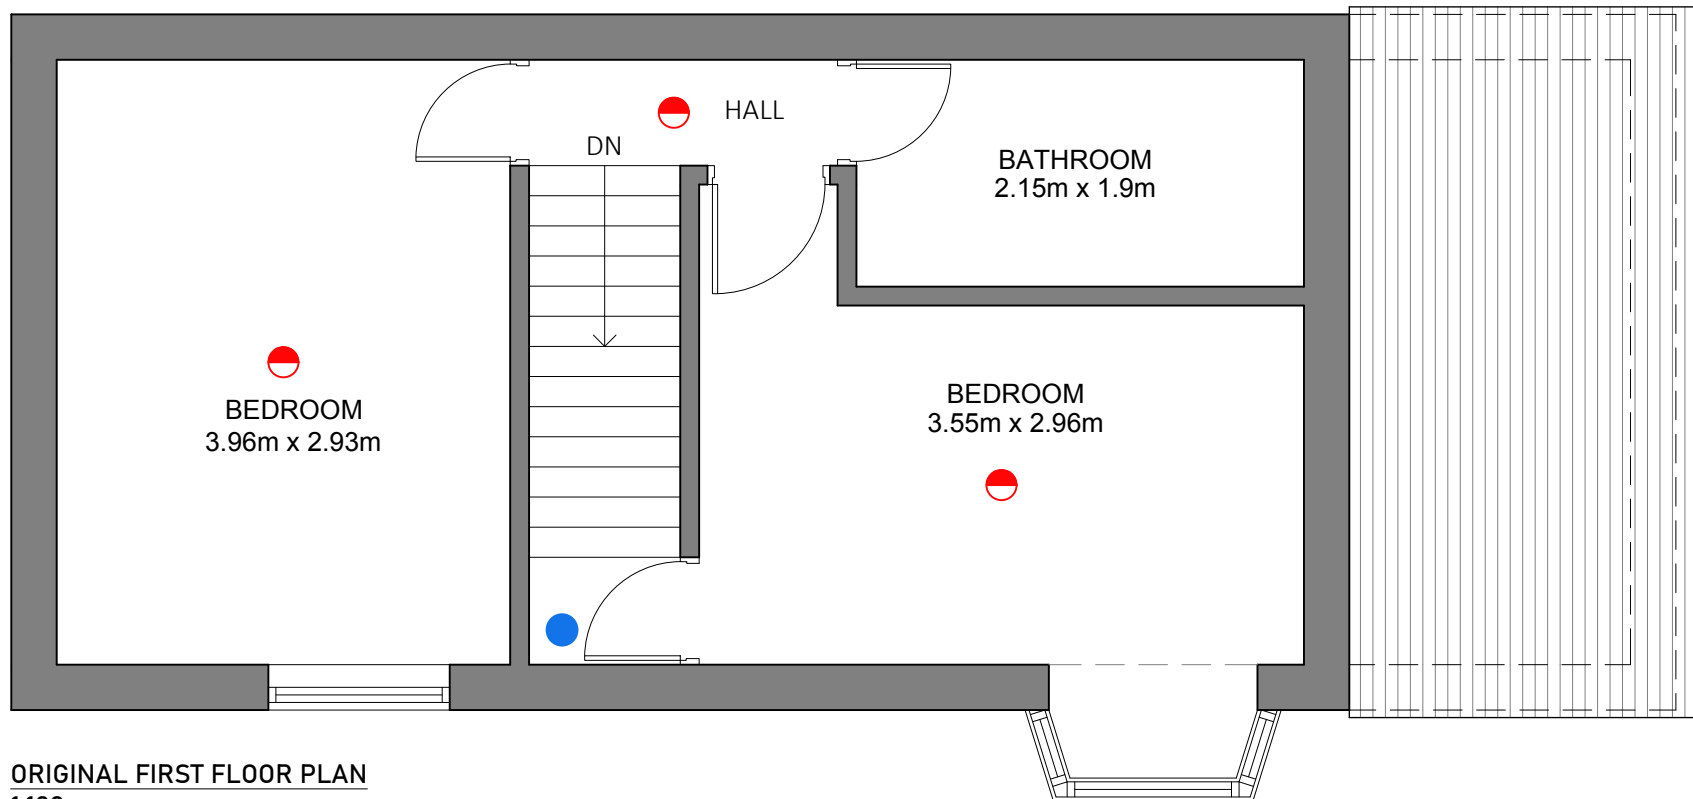

- LEGEND
- Fire alarm
 - Heat detector
 - Carbon Monoxide detector
 - Fire blanket

ORIGINAL FIRST FLOOR PLAN
1:100

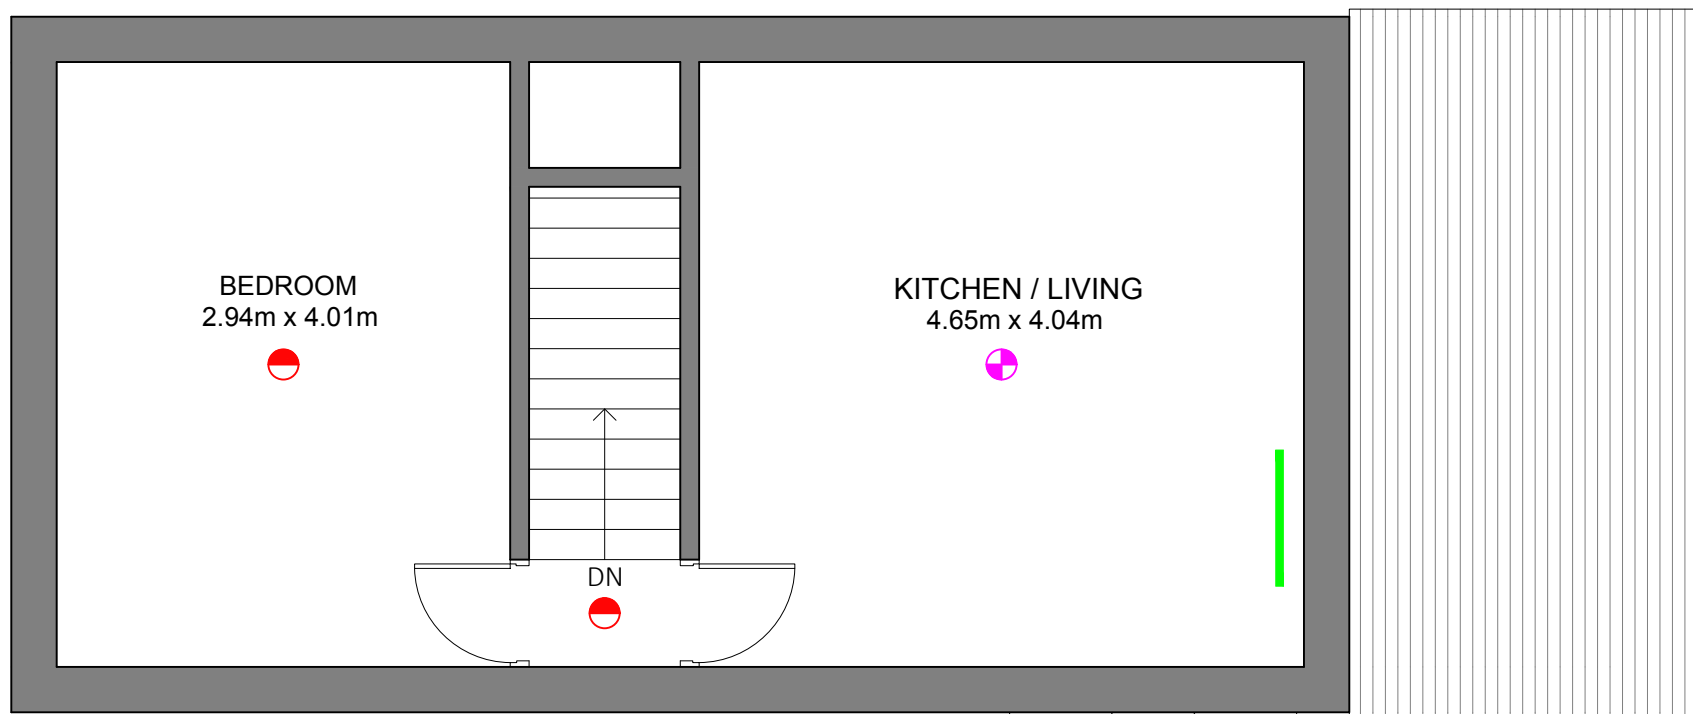

ORIGINAL SECOND FLOOR PLAN
1:100

REV.	DATE	COMMENT	BY	CHK'D
PROJECT ADDRESS:				
2 Drayton road, Portsmouth, PO2 7HW				
TITLE:				
FLOOR PLANS				
SCALE:			1:50 @A3	
SHEET NUMBER:				
PL001				
DATE:			13-06-2024	
DRAWN BY:			MA	
CHECKED BY:			MA	